



B:\Projects\1934-02 Tract C-3 - San Marino\AutoCAD\1934-02-03 DDC\Current\Plan\19020203.dwg
12/16/2017 4:53:41 PM

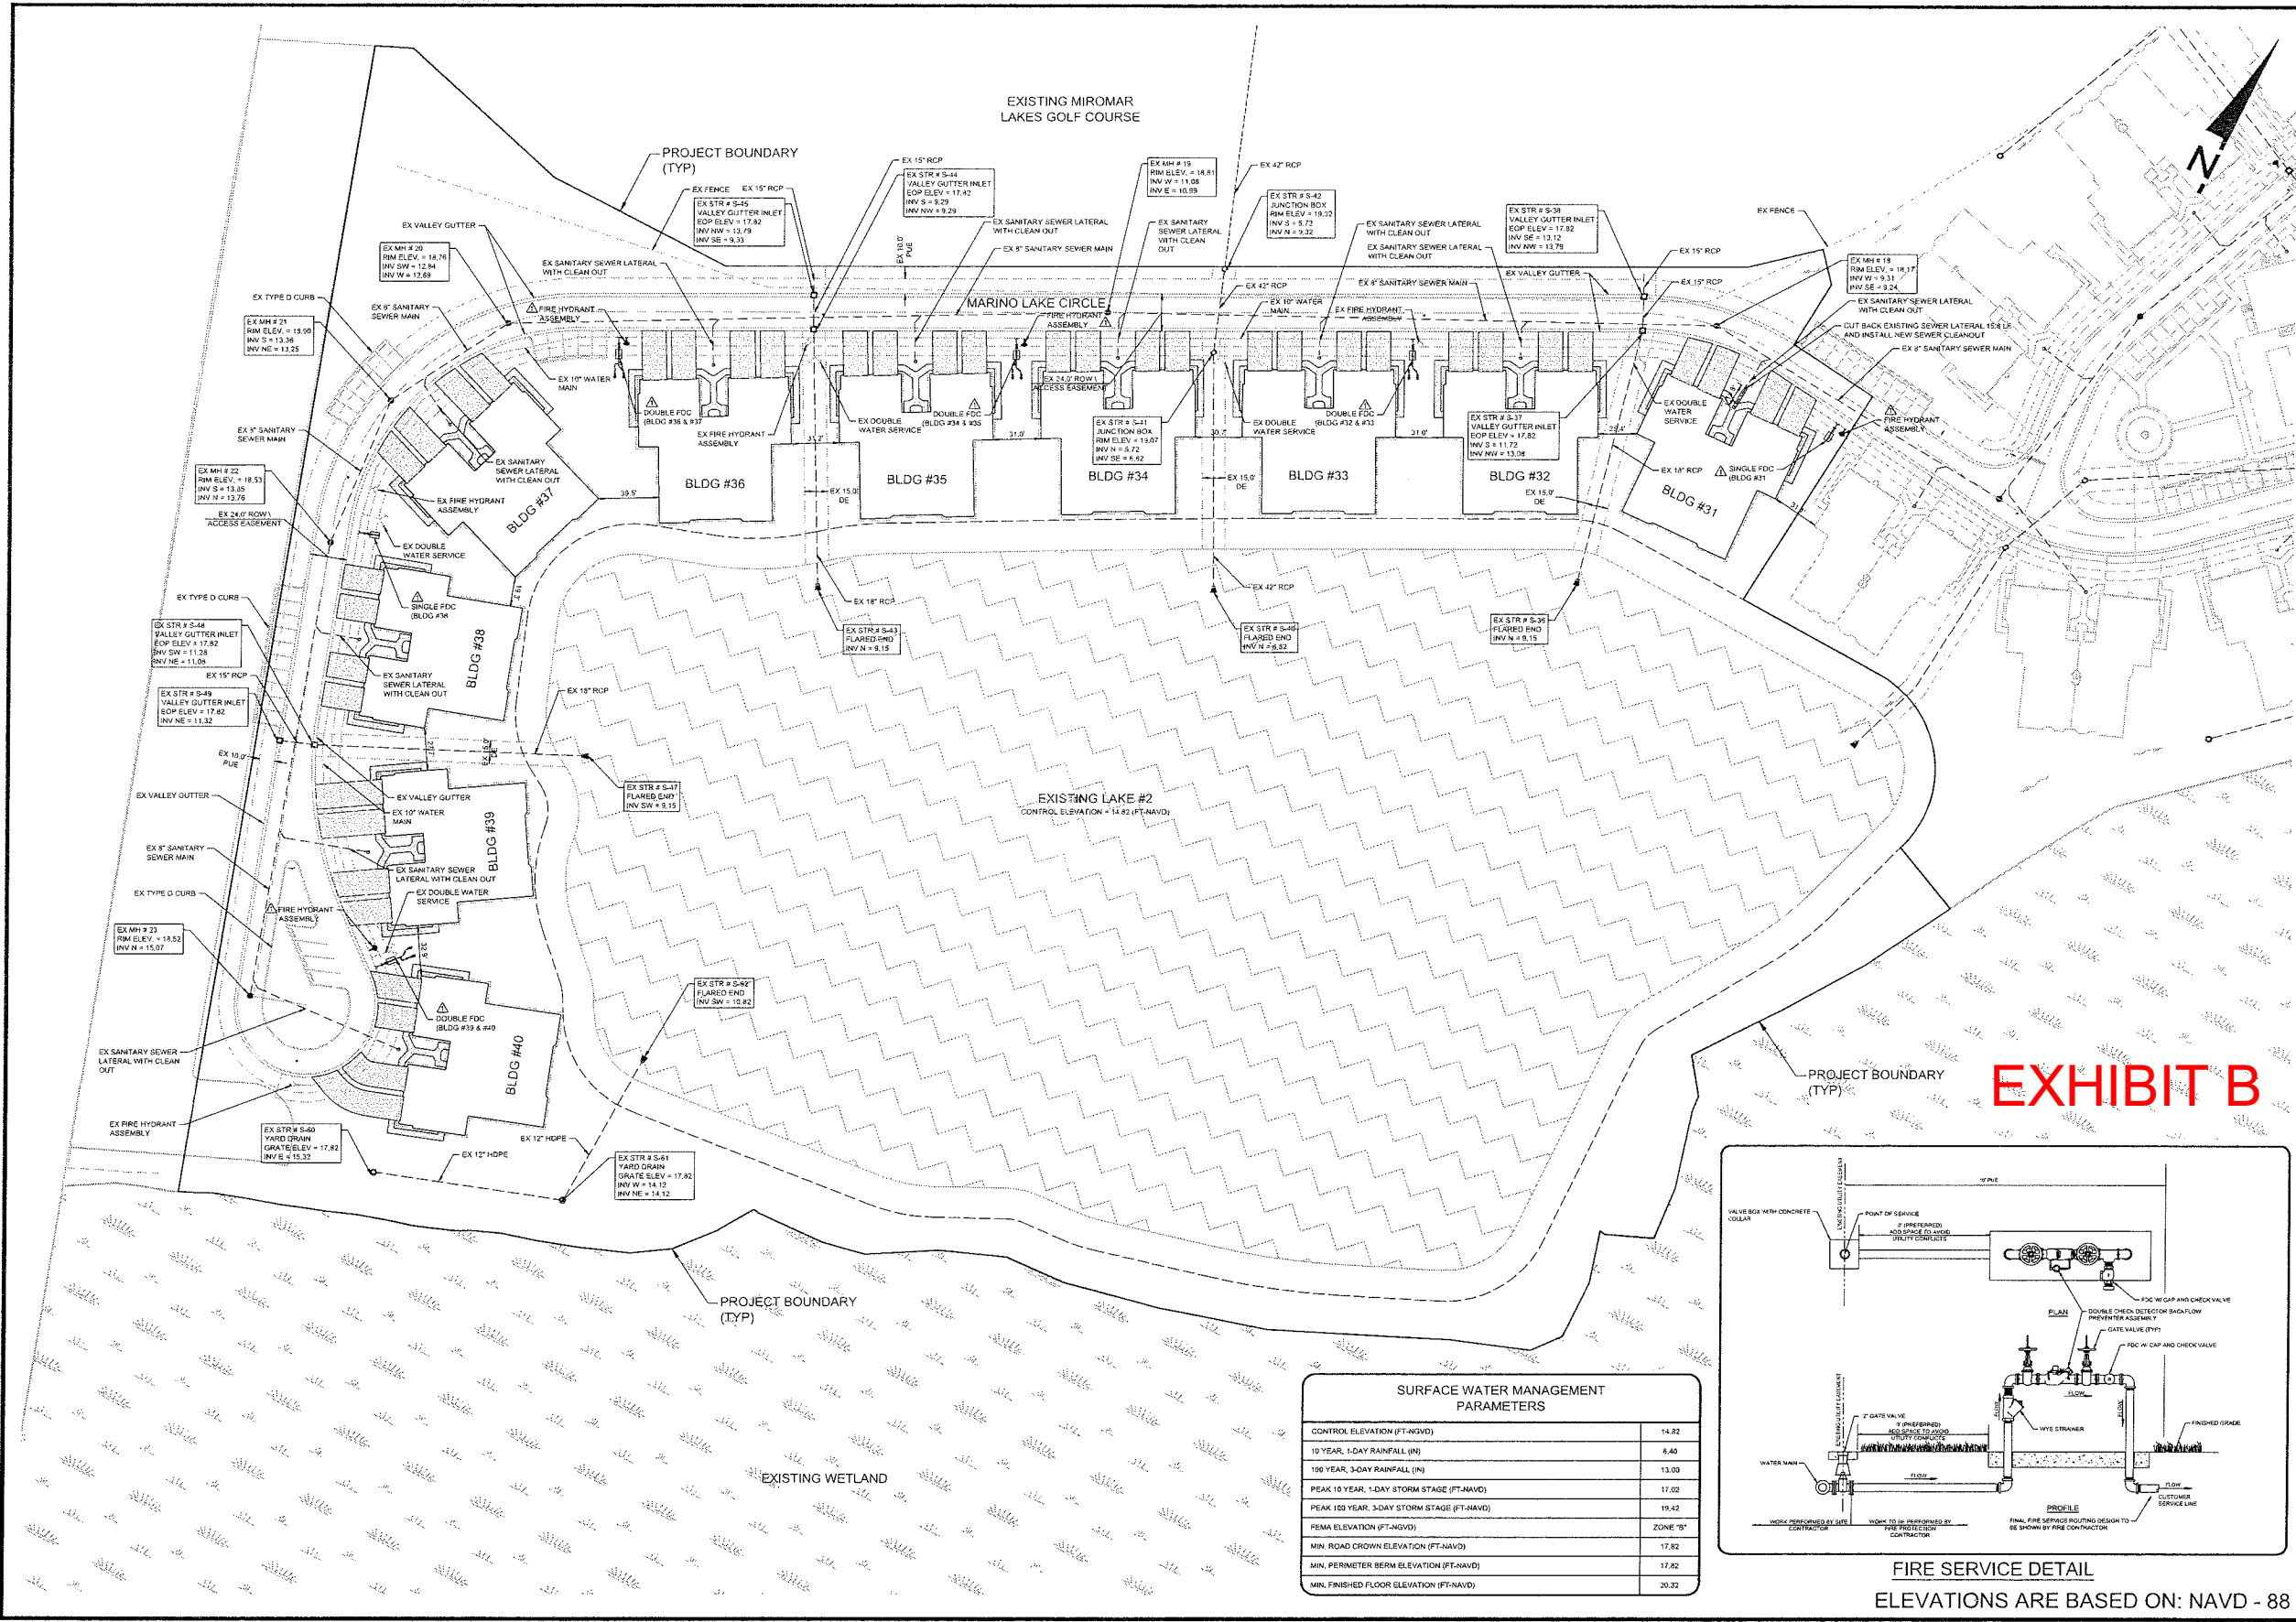

SURFACE WATER MANAGEMENT PARAMETERS	
CONTROL ELEVATION (FT-NAVD)	14.82
10 YEAR, 1-DAY RAINFALL (IN)	6.40
100 YEAR, 3-DAY RAINFALL (IN)	13.00
PEAK 10 YEAR, 1-DAY STORM STAGE (FT-NAVD)	17.02
PEAK 100 YEAR, 3-DAY STORM STAGE (FT-NAVD)	19.42
PEMA ELEVATION (FT-NGVD)	ZONE '5'
MIN. ROAD CROWN ELEVATION (FT-NAVD)	17.82
MIN. PERIMETER BERM ELEVATION (FT-NAVD)	17.82
MIN. FINISHED FLOOR ELEVATION (FT-NAVD)	20.32

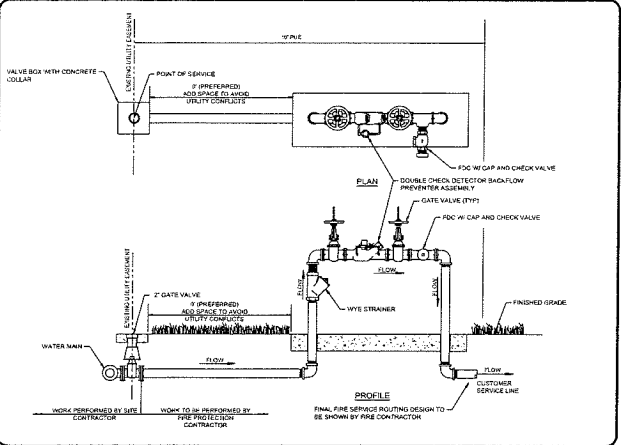

FIRE SERVICE DETAIL
ELEVATIONS ARE BASED ON: NAVD - 88

**WALDROP
ENGINEERING**

25100 BONTA GRANDE DRIVE - SUITE 307, BONTA SPRINGS, FL 34135
P: 239-405-7177 F: 239-405-7389 EMAIL: info@waldropengineering.com


DEVELOPMENT ORDER PLANS FOR
SAN MARINO
PHASE II
CLIENT: SAN MARINO II AT MIROMAR LAKES, LLC
MASTER SITE, UTILITY, AND DRAINAGE PLAN

PLAN REVISIONS
REV 001 - SUBMITTED BIG SET - 6/26/17
REV 002 - REVISED PER COUNTY COMMENTS
REV 003 - REVISED PER COUNTY COMMENTS

0 25 50 100
SCALE IN FEET

FLORIDA CERTIFICATE OF AUTHORIZATION #6635

JEREMY H. ARNOLD, P.E.
FL. LICENSE NO. 44417
SET NUMBER: 108-02-03
SHEET: 3

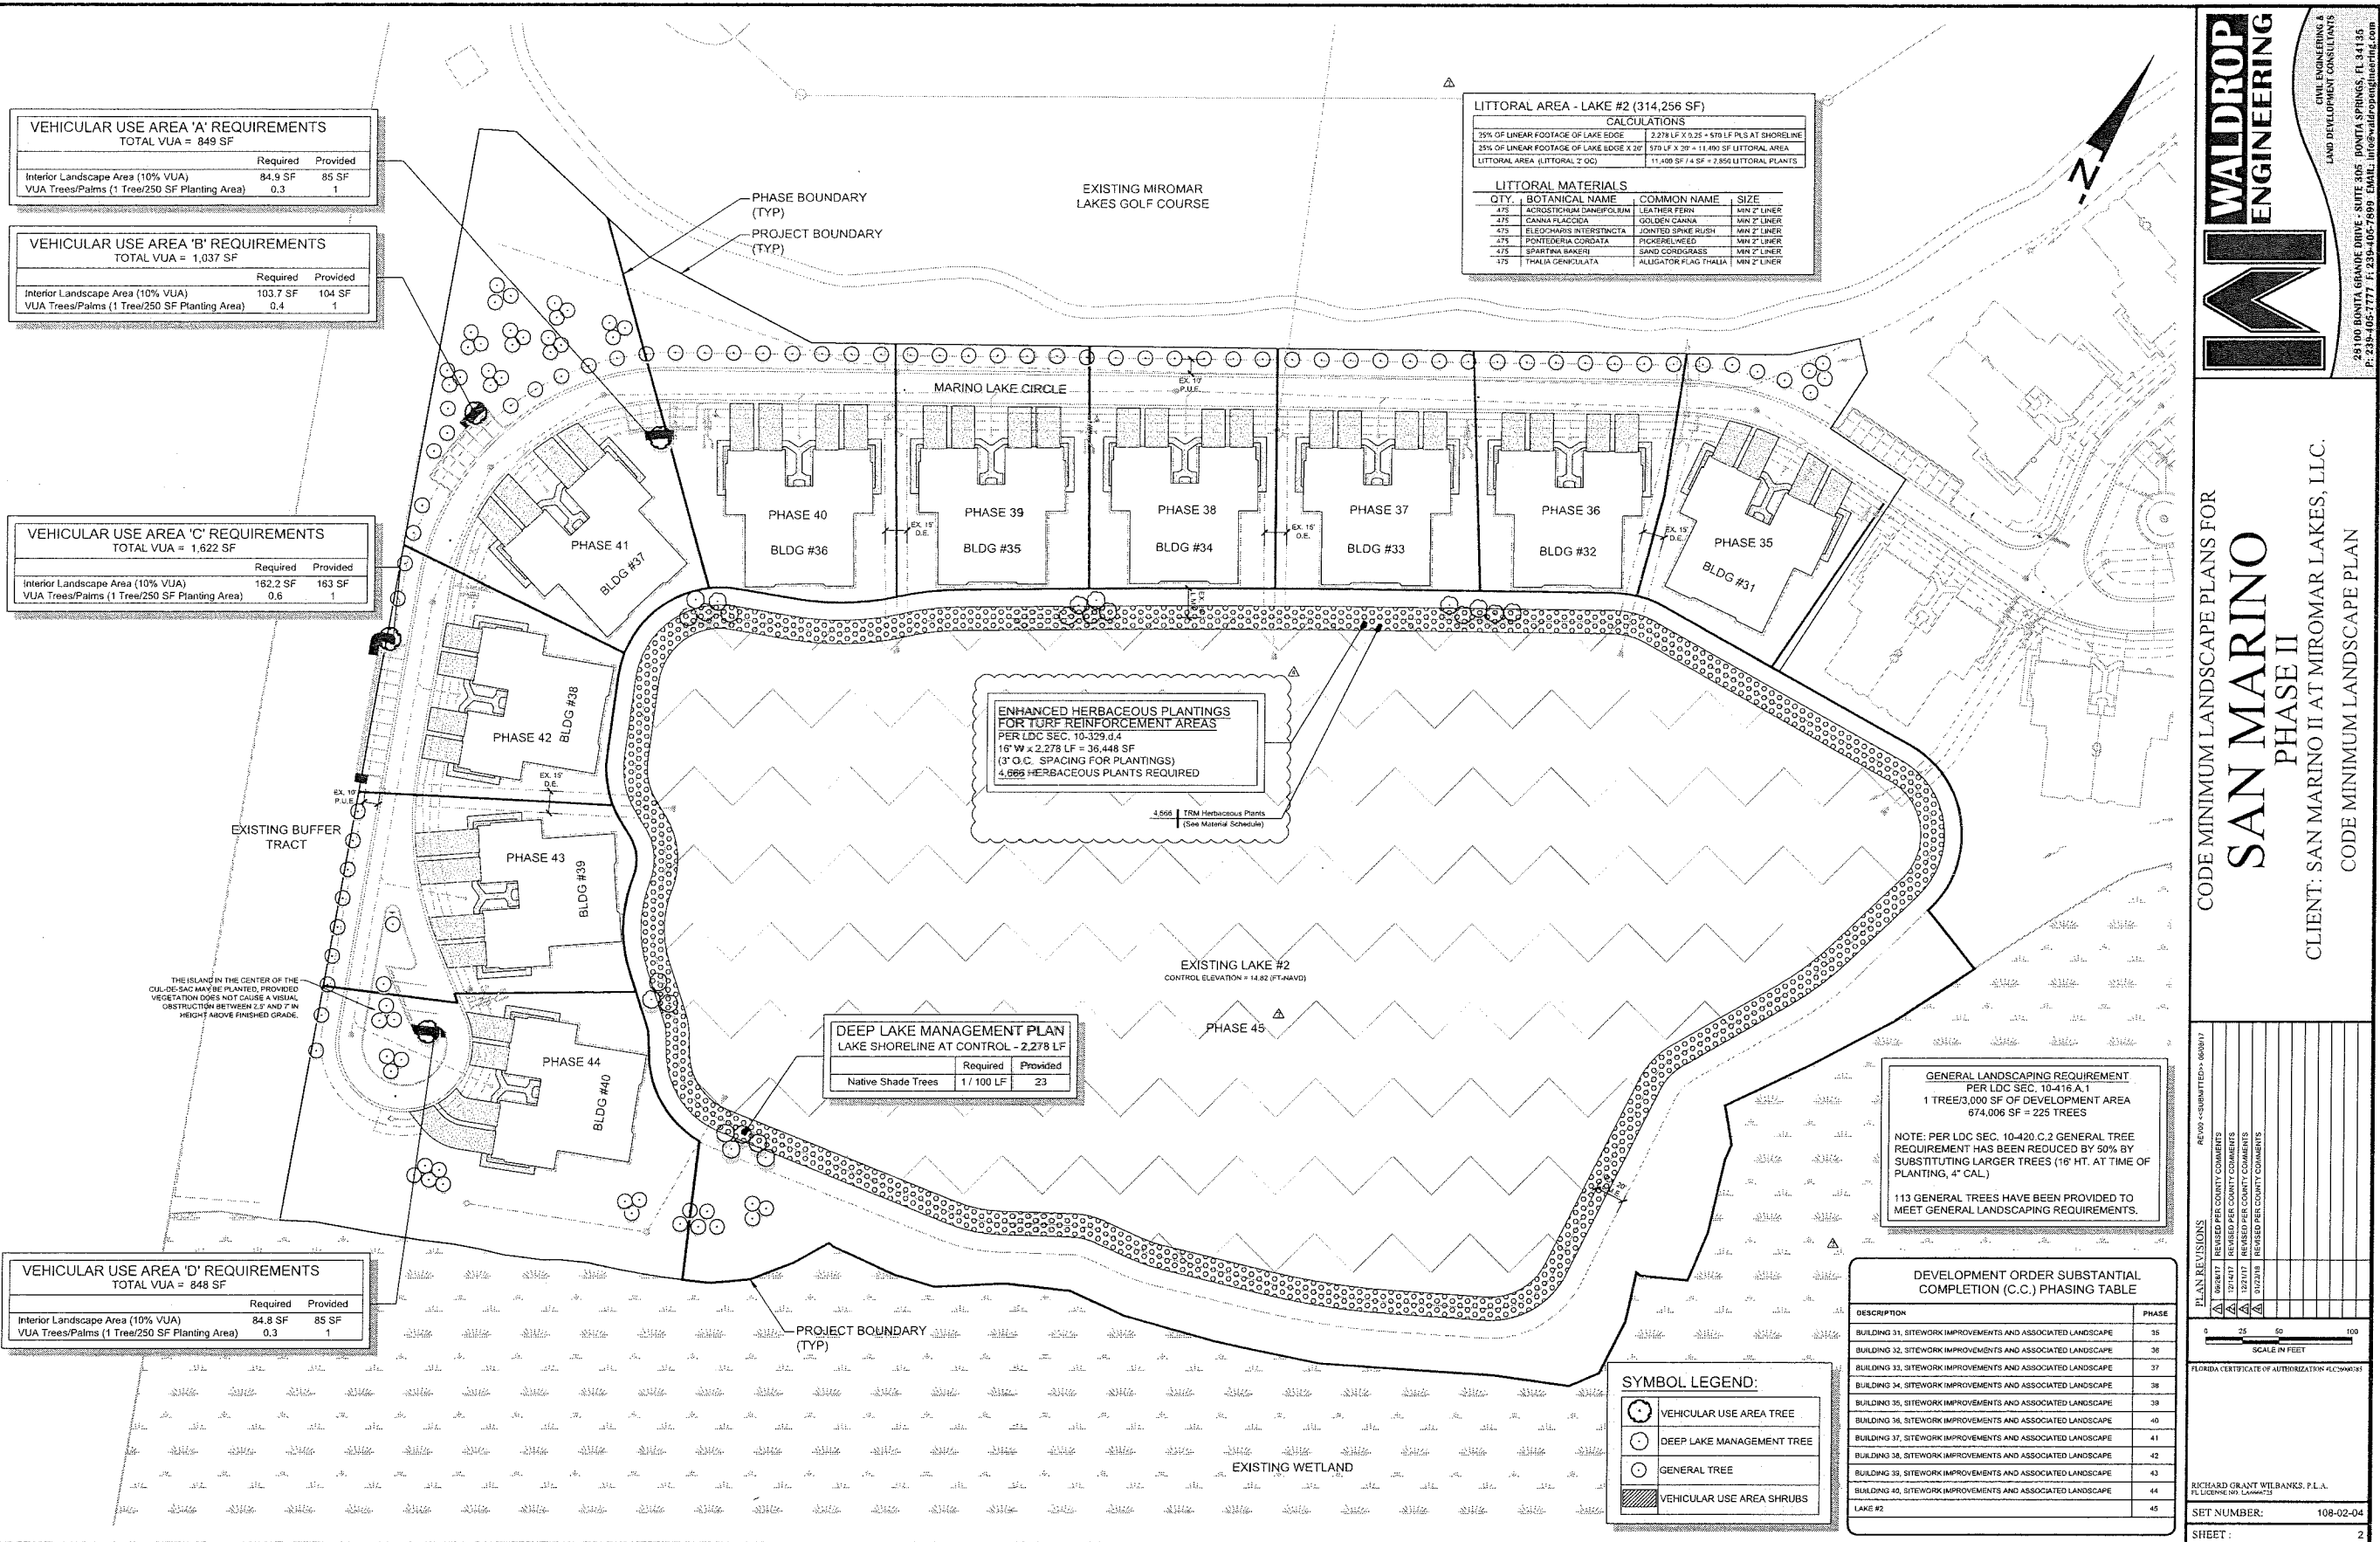

SCALE: 1" = 10'

